




FIESTA GUADALAJARA EXPANSION - FLOOR PLAN EXHIBIT

APRIL 26, 2018

SCALE: 1/8" = 1'-0"

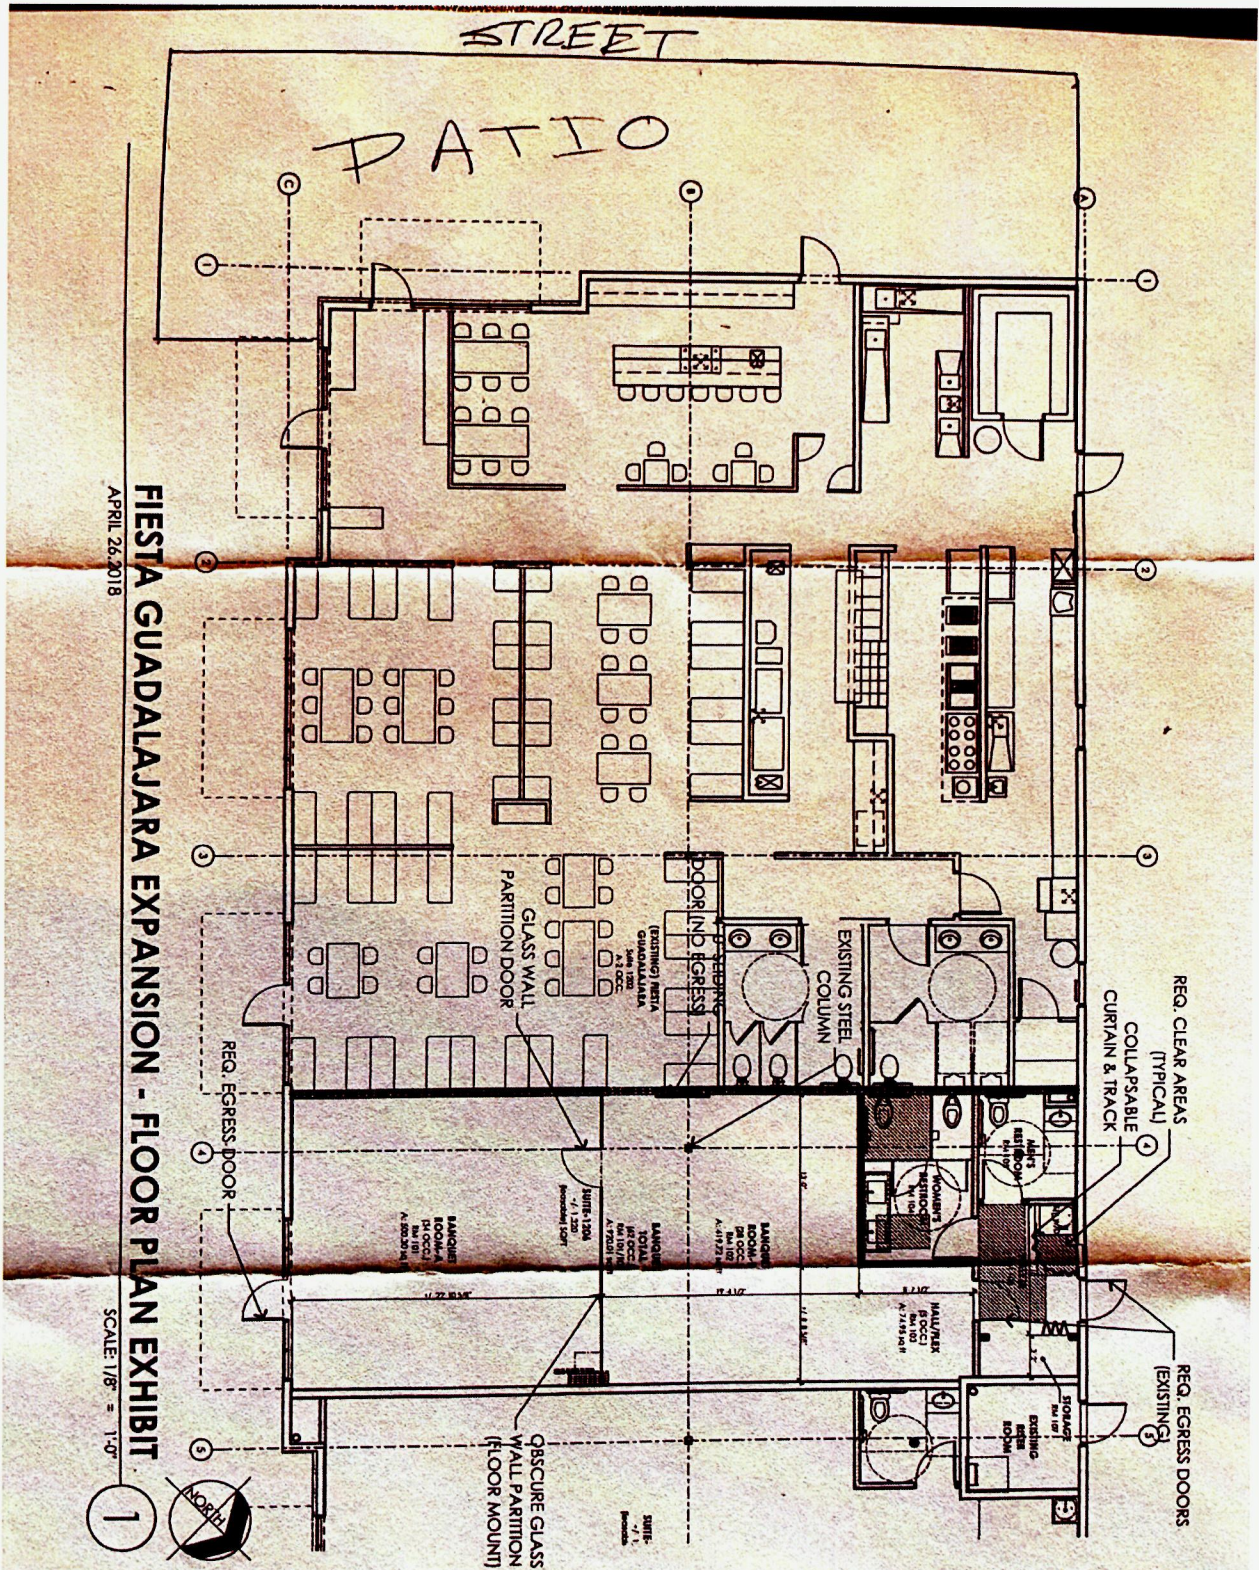

Existing 5  
50% Molt  
2 W.C. M  
3 W.C. Fe

New 3pc  
50% Molt  
1 W.C. M  
2 W.C. Fe

Idaho Plumbing Code Fixture Count / Occupancy

| Male   | Female | Male   | Female | Male   | Female | Male   | Female |
|--------|--------|--------|--------|--------|--------|--------|--------|
| 1-1-25 | 1-1-25 | 1-1-25 | 1-1-25 | 1-1-25 | 1-1-25 | 1-1-25 | 1-1-25 |

*updated map*

RECEIVED  
AUG 14 2023

IDAHO STATE POLICE  
ALCOHOL BEVERAGE CONTROL

PREMISE ID 2C-378