


RECEIVED
 SEP 12 2008
 IDAHO STATE POLICE
 ALCOHOL BEVERAGE CONTROL

(B1) FLOOR PLAN
 SCALE: 1/8" = 1'-0"

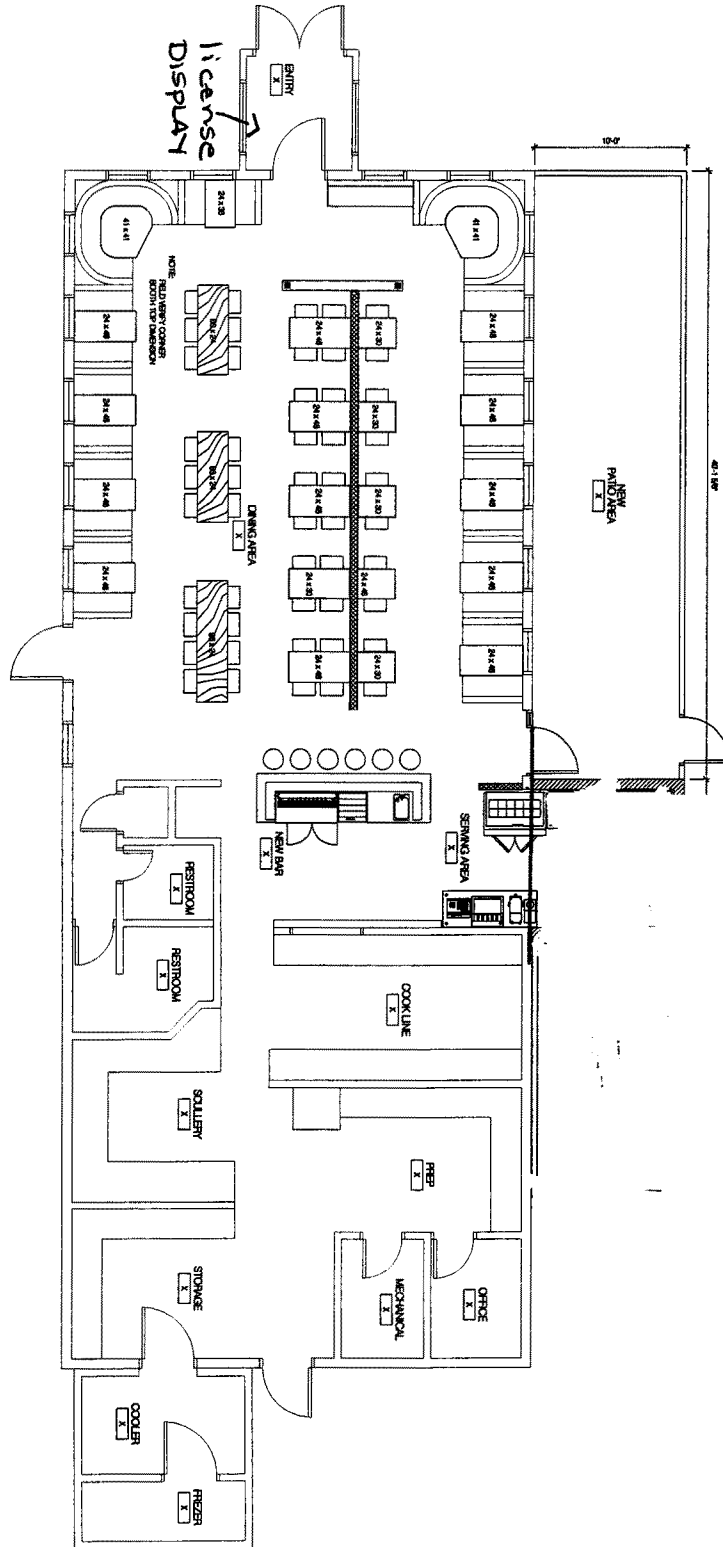

GENERAL NOTES

REFERENCE NOTES

113-127
 License ID

A-100

FLOOR
 PLAN

DATE: 11/11/08
 DRAWN BY: J. WINGERS
 CHECKED BY: J. WINGERS

WINGERS - POCATELLO
 969 YELLOWSTONE AVE
 POCATELLO, IDAHO 83201

FFKR ARCHITECTS
 730 Pacific Avenue • Salt Lake City, Utah 84104
 O 801.521.6186 • FFKR.COM