



OCT - 2 2012

RECEIVED

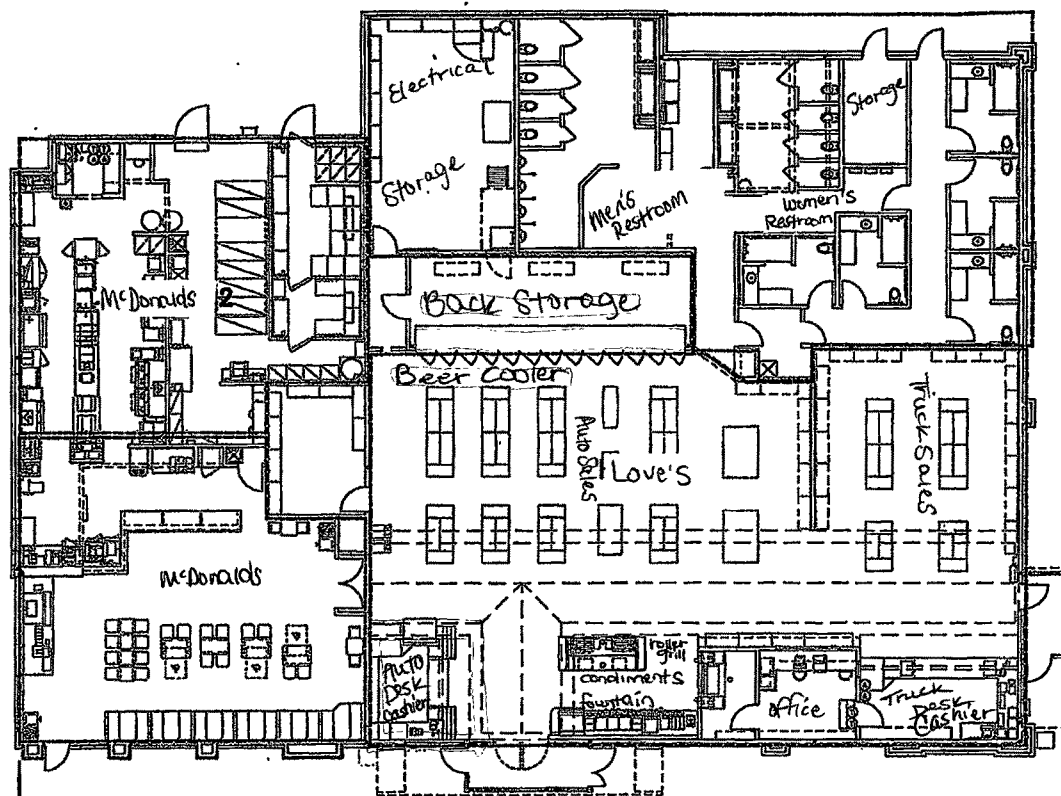


1 FLOOR PLAN - TEMPERATURE CONTROL
SCALE: 1/16" = 1'-0"

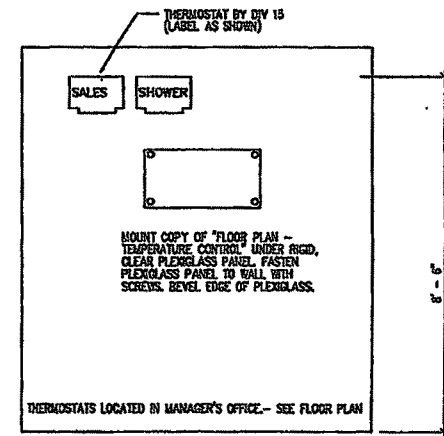


2 THERMOSTAT INSTALLATION
SCALE: NONE

NOTE:
USE TWO SEPARATE SHIELDED CABLES
CONTAINING 20 AWG MINIMUM, TWISTED PAIR
CONDUCTORS WITH OVERALL SHIELD, BELDEN
TYPE 8782 OR 88780 (PLENUM) OR
EQUIVALENT. CONNECT BOTH CABLES SHIELD
DRAIN WIRES AS SHOWN.

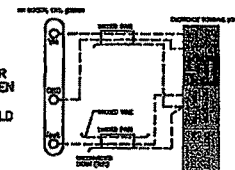


3 HUMIDISTAT FIELD WIRING
SCALE: NONE

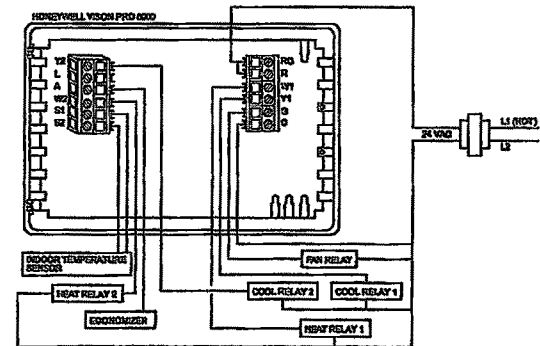

4 TYPICAL 2H/2C MULTISTAGE THERMOSTAT WIRING
SCALE: NONE



 405.453.2404
Fax 405.453.2403
6305 North State Street
Boise, Idaho 83725
pcc@idaho.gov



TRAVEL STOP
RE No. 478
IDAHO FALLS, ID

Love's
Travel Stops &

Revised: _____
Date: _____
Project No: LWS-11402
Order: 01-25-12
Sheet No: _____
M3.2
of