



Premise ID 1A-14510

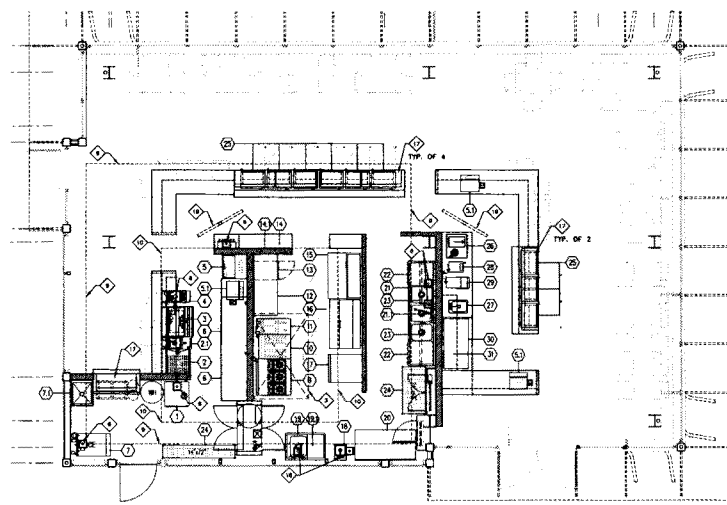

equipment plan
SCALE: 1/4" = 1'-0"

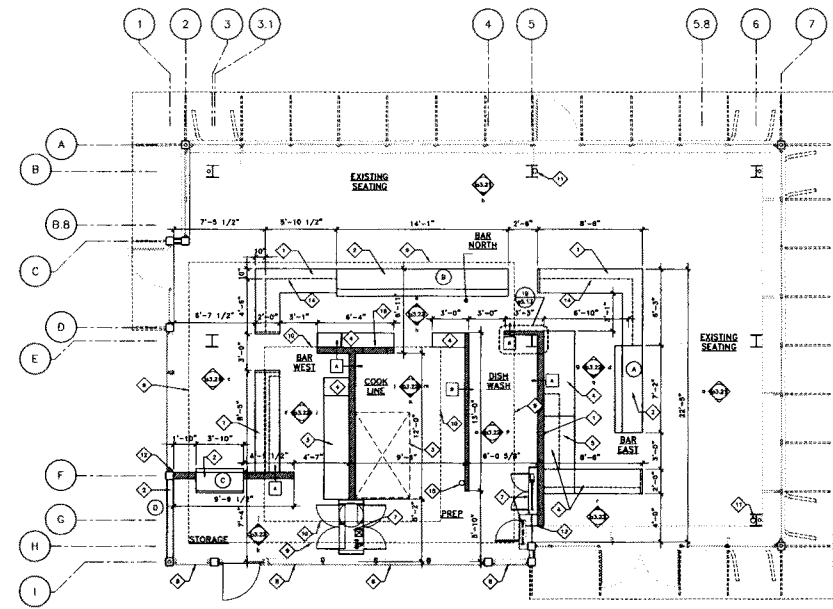

floor plan
SCALE: 1/4" = 1'-0"

ITEM NO.	SUPPLIER	DESCRIPTION	MANUFACTURER
1	...	...	...
2	...	...	...
3	...	...	...
100	...	...	...

wall type:

RECEIVED

MAR 22 2018

legend

- ===== NEW PARTITION WALL AS SCHEDULED
- == WALL BELOW COUNTERTOP
- EXISTING DOOR TO REMAIN
- WALL TYPES - SEE THIS SHEET
- WINE WALL TYPES - SEE SHEET 45.11
- EQUIPMENT - SEE EQUIPMENT SCHEDULE

general notes:

- CONTRACTOR TO VERIFY ALL DIMENSIONS IN FIELD. NOTIFY ARCHITECT IF DISCREPANCIES ARE FOUND.
- GYPSUM WALLBOARD APPLICATION & FINISHING AT ALL EXPOSED SURFACES TO COMPLY WITH SPECIFICATIONS AND/OR WITH ANSI LEVEL 2.
- UNLESS NOTED OTHERWISE ALL INTERIOR PARTITIONS ARE DIMENSIONED TO FACE OF STUD.
- FIRE EXTINGUISHERS TO BE WALL MOUNTED. VERIFY FINAL LOCATIONS WITH FIRE MARSHALL. REFER TO 18/45.13 FOR DETAILS.
- REFER TO EQUIPMENT DRAWINGS FOR EQUIPMENT PLANS.
- REFER TO 45.21-45.22 FOR FLOOR FINISHES, INTERIOR ELEVATIONS & FINISH SCHEDULE.
- INSTALL CORNER DRAINERS AT ALL EXPOSED OUTSIDE CORNERS. SEE SPECIFICATIONS.
- PROTECT AND RETAIN EXISTING BASEMENT FLOOR SYSTEM LOCATED UNDER EXISTING 1ST FLOOR STONE TILE. DO NOT PENETRATE HYDRATING TUBING.
- COORDINATE WITH MECHANICAL, PLUMBING AND ELECTRICAL DRAWINGS FOR ADDITIONAL INFORMATION.
- COORDINATE WITH OWNER FOR FINAL SPECIFICATIONS OF ALL EXISTING EQUIPMENT.
- CONTRACTOR TO VERIFY AND COORDINATE BLOCKING REQUIRED TO SUPPORT ALL WALL MOUNTED ITEMS.
- PROVIDE 8" HIGH FRP PANELS, WHITE AT ALL WALL AND COLUMN FACES AT BACK BAR FOR AND STORAGE 110.

keynotes:

- NEW BAR COUNTER AND BASE, SEE INTERIOR ELEVATIONS AND MILLWORK DETAILS.
- NEW "WINE WALL", SEE INTERIOR ELEVATIONS AND MILLWORK DETAILS.
- EXISTING HOOD.
- NEW MILLWORK, SEE INTERIOR ELEVATIONS AND MILLWORK DETAILS.
- COUNTER TOP, OFFER BELOW FOR NEW EQUIPMENT, SEE EQUIPMENT PLAN AND KITCHEN LAYOUT DRAWINGS.
- NEW FLOOR TING, SEE PLUMBING PLANS.
- EXISTING UTILITY/ELECTRICAL PANELS, SEE ELECTRICAL DRAWINGS.
- EXISTING GLAZING TO RECEIVE OPAQUE/DECORATIVE WINDOW FILM. COORDINATE WITH ARCHITECT.
- LINE OF SUSPENDED WOOD PANEL CEILING ABOVE, SEE SHEET 45.31.
- LINE OF SUSPENDED 2" X 2" METAL PANEL GRID CEILING, SEE SHEET 45.31.
- FIRE EXTINGUISHER, EXISTING.
- ADJUST NEW WALL WITH EXISTING COLUMN.
- ADJUST NEW WALL WITH EDGE OF EXISTING COLUMN.
- TOP TO LINE EXTERIOR WALL UNDER COUNTERTOP OR UP TO ADJACENT COUNTERTOP HEIGHT BEHIND ALL EQUIPMENT, SEE INTERIOR ELEVATIONS.
- TYPE "X" FIRE EXTINGUISHER.
- FAST THIS WALL OPENING, SEE INTERIOR ELEVATIONS.
- WINE DISPENSERS PROVIDED BY OWNER / CONTRACTOR TO INSTALL. CONTRACTOR TO PROVIDE ABOVE GAS LINE (WINE GAS) & COMPRESSED AIR LINE (2 FOR EACH UNIT). 1 POWER OUTLET FOR AIR COMPRESSOR LOCATED NEAR GAS STORAGE AREA (UNIT 2 COMPRESSORS), AND 1 DATA LINE PER UNIT.
- EXISTING FLOOR FIN, SEE PLUMBING DRAWINGS.
- EXISTING CEILING MOUNT TV, SEE SHEET 45.31 AND ELECTRICAL DRAWINGS.

IDAHO STATE POLICE
ALCOHOL BEVERAGE CONTROL

Bodovino - The Village • Meridian
Pavilion 'B' Tenant Improvement
3630 E. Monarch Sky Lane
Meridian, Idaho 83642

project: 181211
date: 04.05.18
drawn: [blank]
checked: H,ae

permit
set

equipment +
floor plan
a2.11