


MASTER FLOOR PLAN
1-28-07

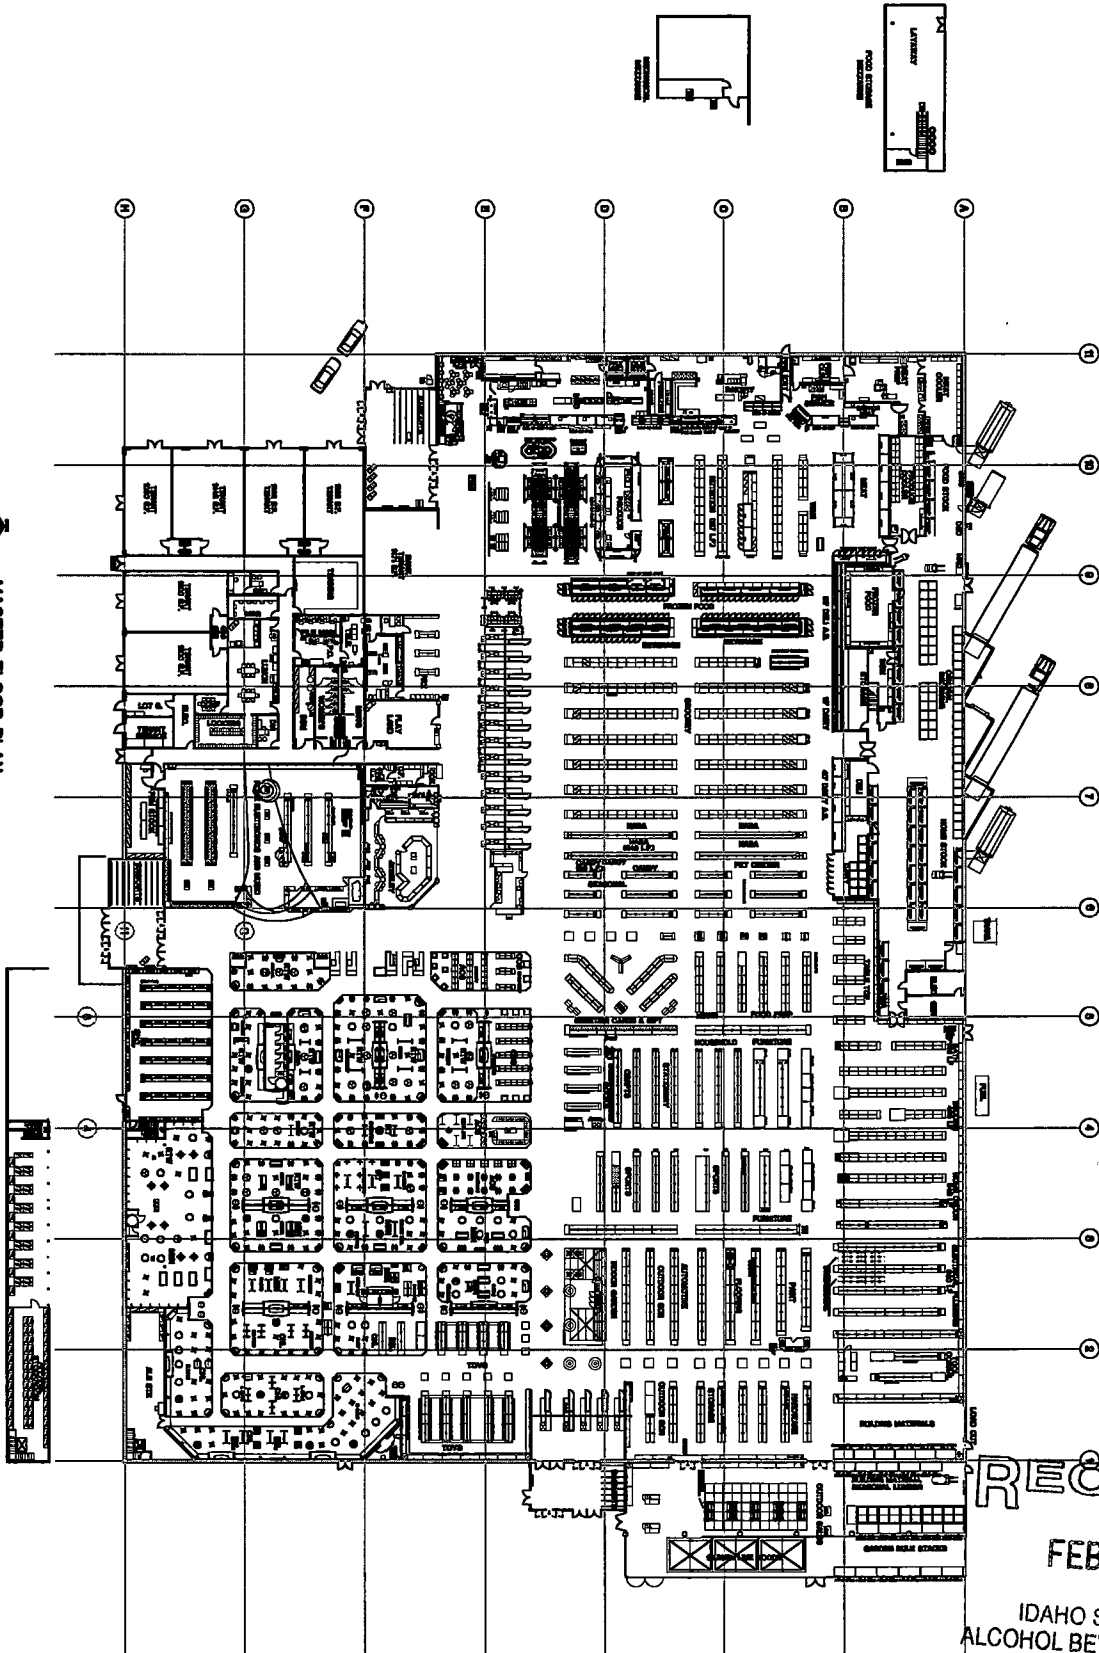

ANNED

RECEIVED

FEB 16 2007

IDAHO STATE POLICE
ALCOHOL BEVERAGE CONTROL

00198 - MERIDIAN		Fred Meyer 3300 S.E. 22nd Avenue Portland, Oregon 97202 Telephone (503) 232-5844 Fax (503) 787-3539
DATE OF 08 FEB 07 1/25-4-07 ALPLOT FUTURE SHEET NO. 1 OF 1		