


1 MASTER FLOOR PLAN SCHEME 4

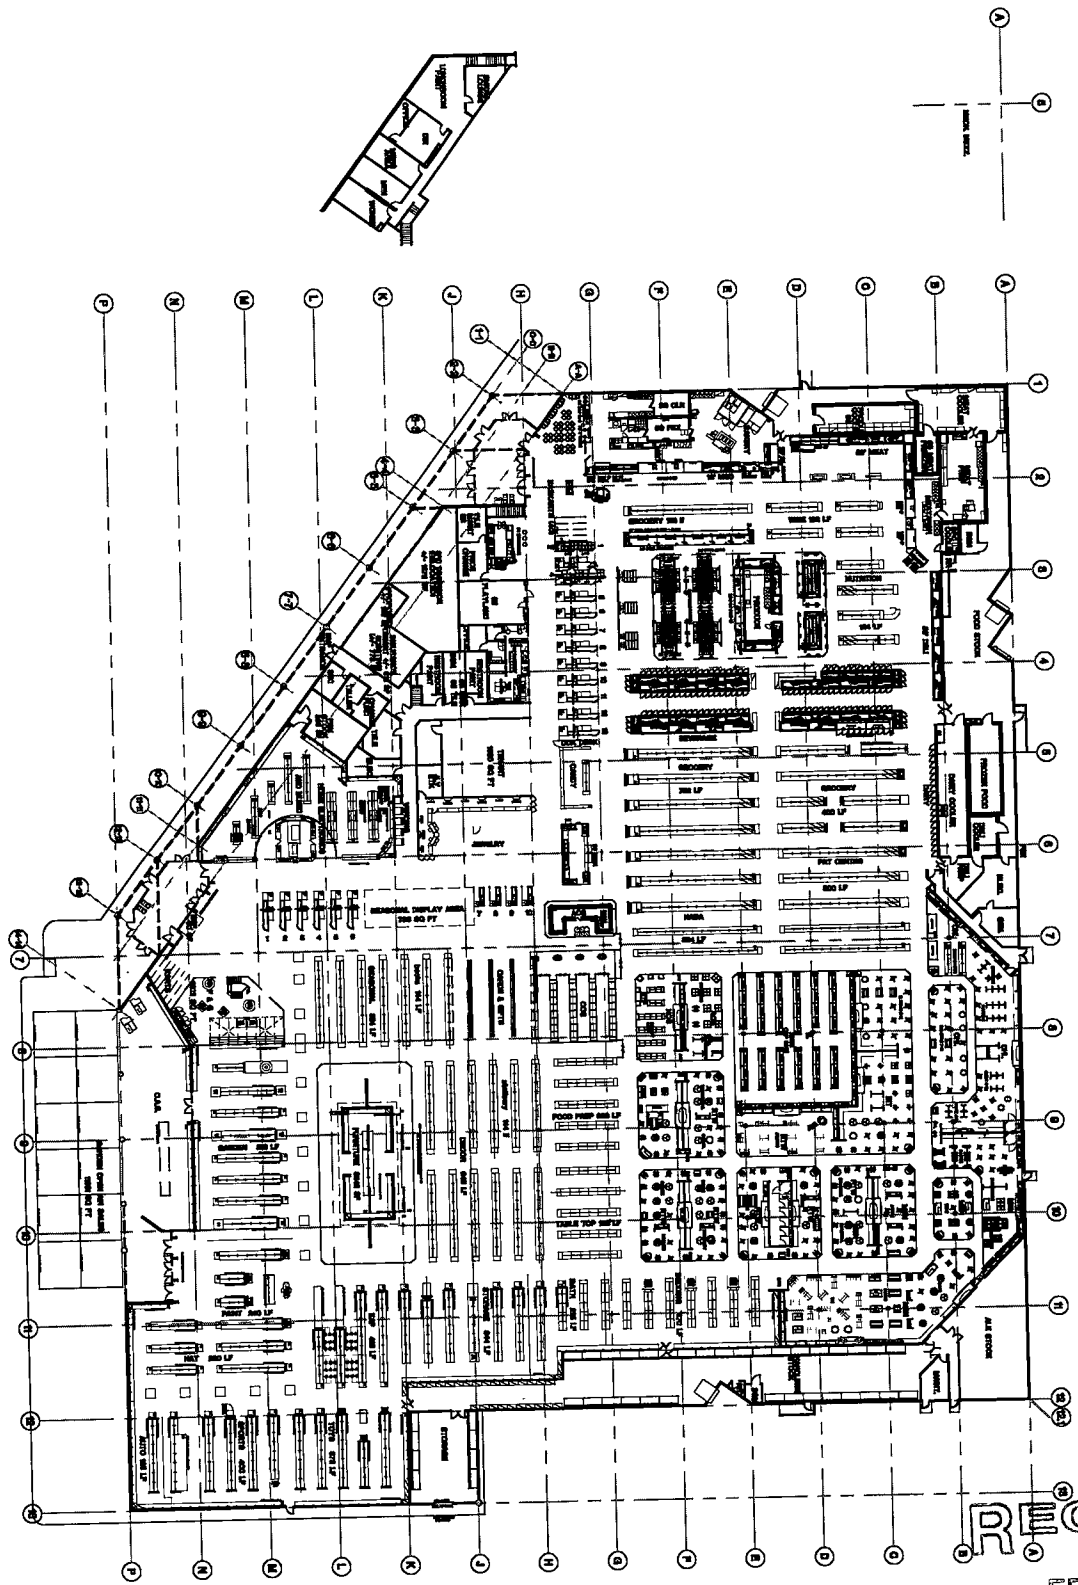

RECEIVED

FEB 16 2007

SCANNED IDAHO STATE POLICE
ALCOHOL BEVERAGE CONTROL

00449 - IDAHO GLENWOOD		Fred Meyer 3800 S.E. 22nd Avenue Portland, Oregon 97202 Telephone: (503) 232-8844 Fax: (503) 797-3639	
DRAWN BY CHS DATE 08 FEB 07	CHECKED BY RMY DATE 08 FEB 07	PROJECT NO. PM449-2	SHEET NO. 1 OF 1